


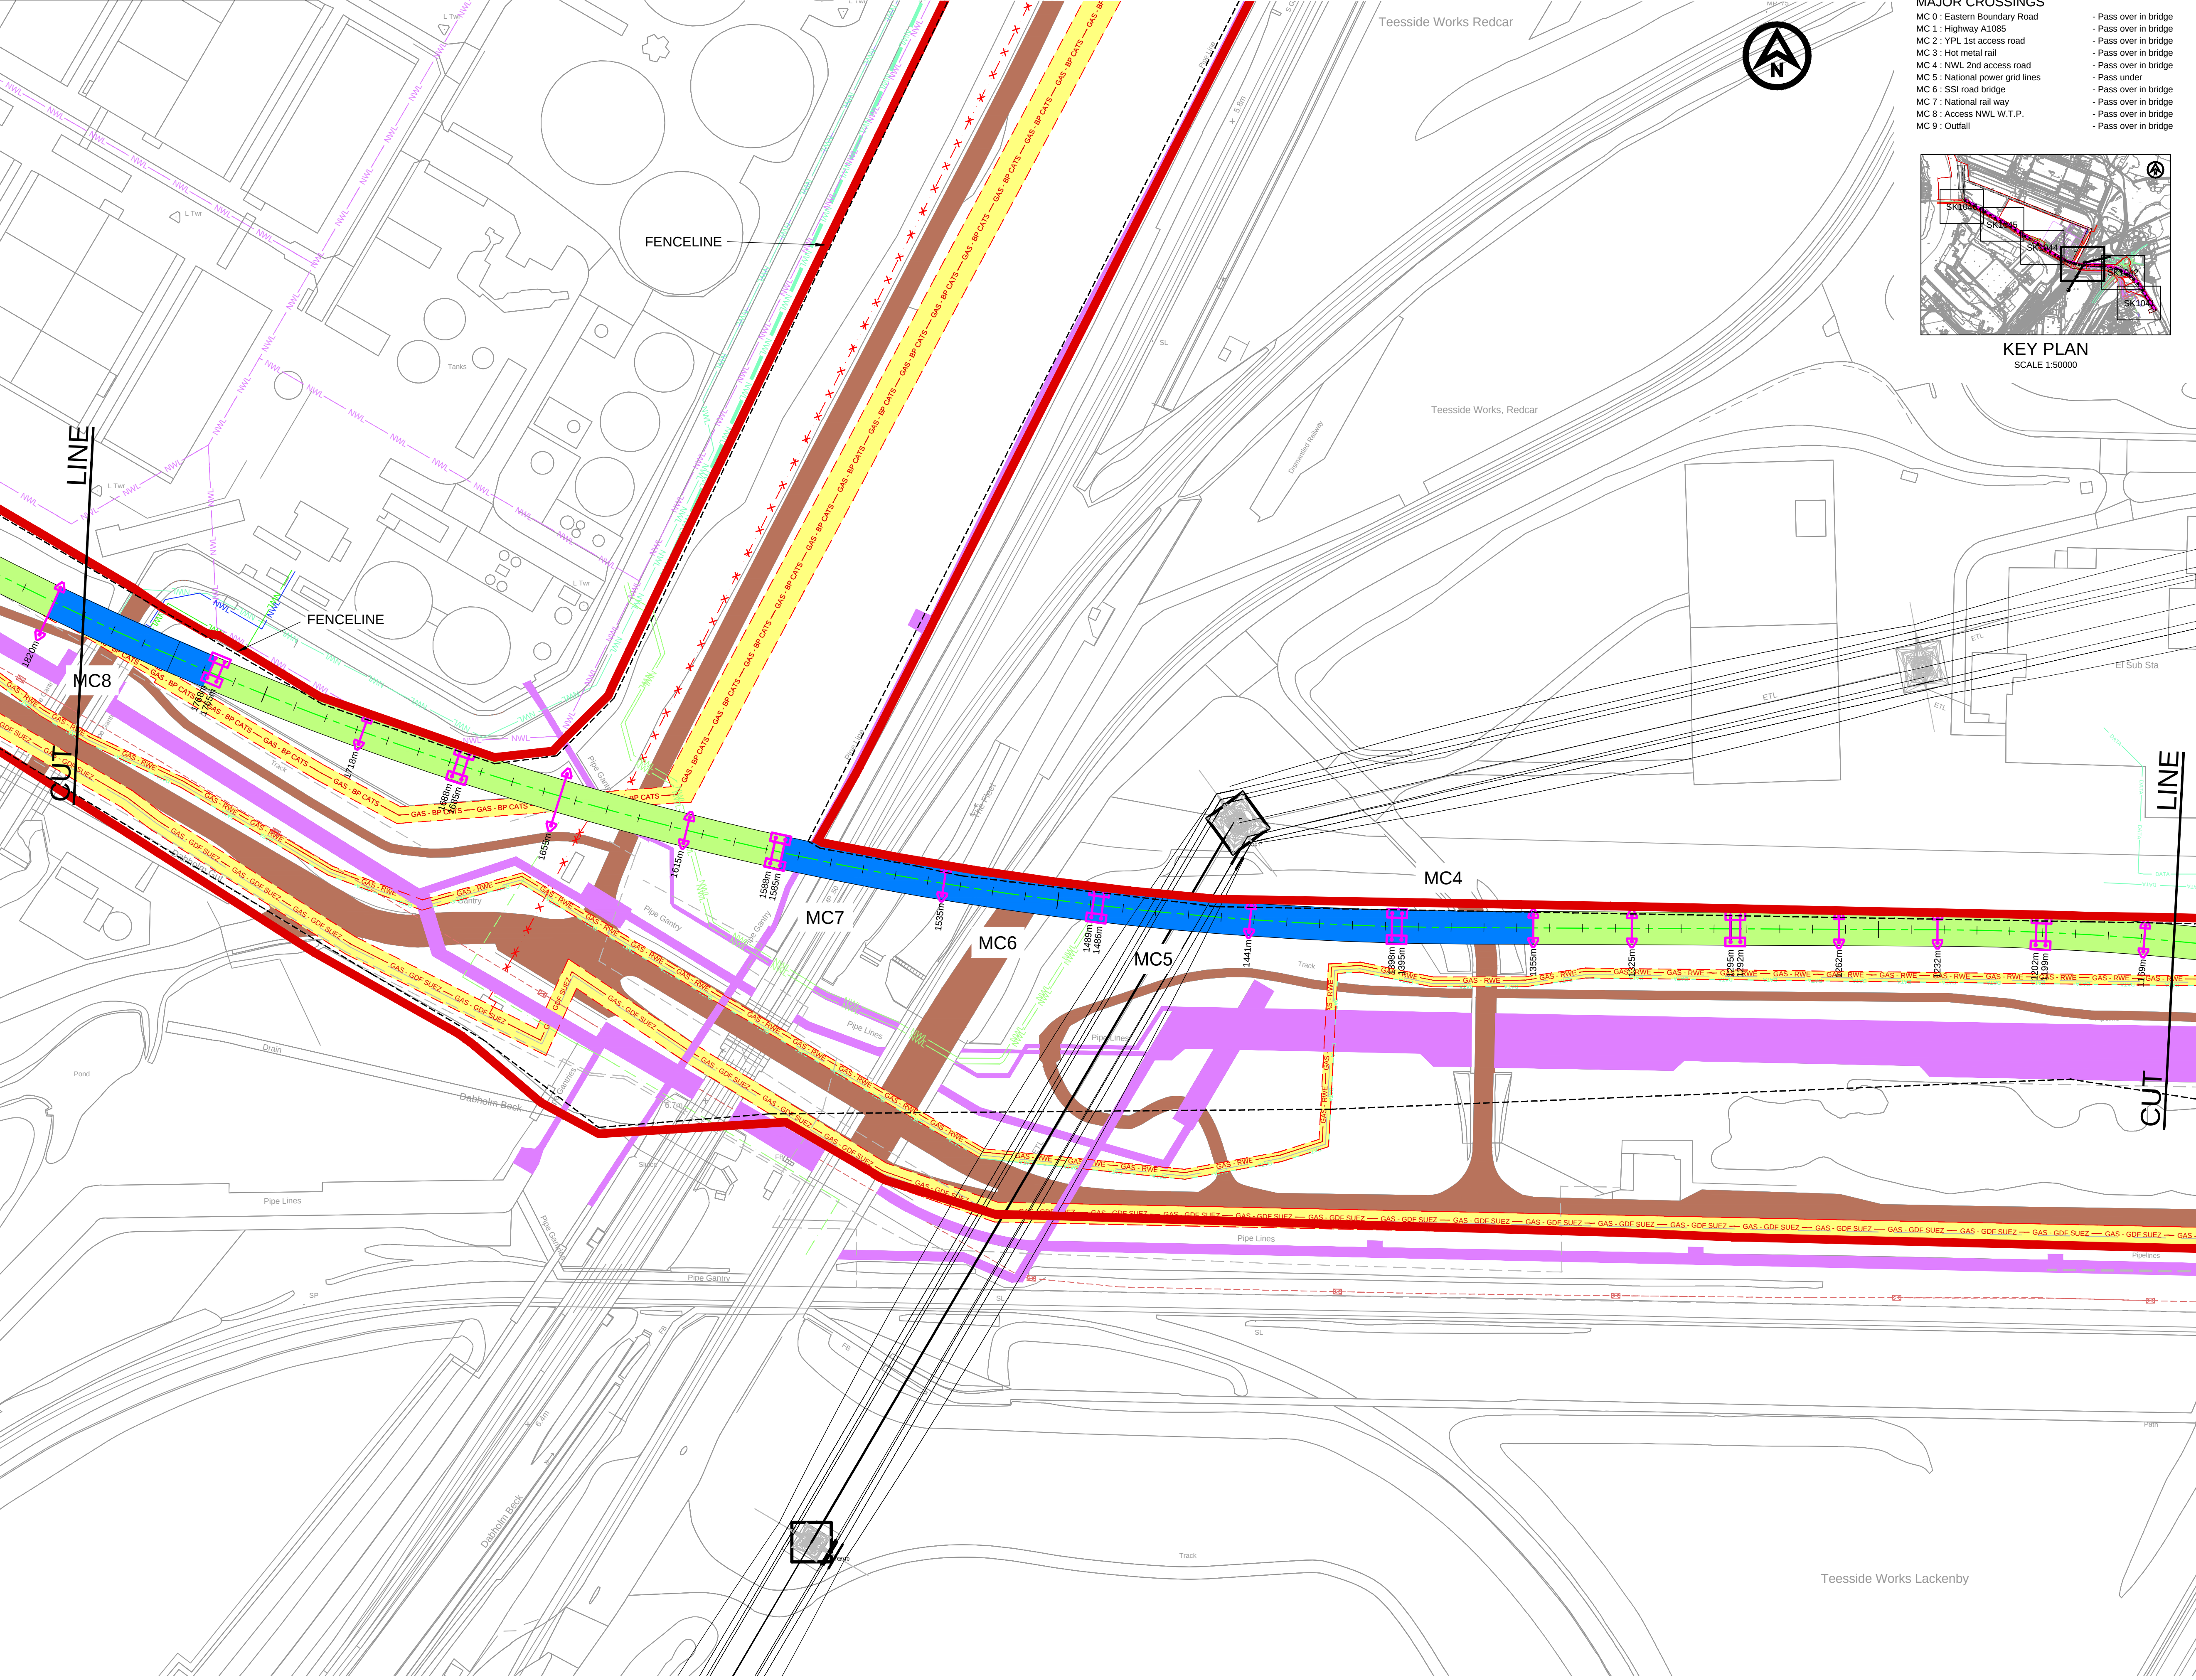

MAJOR CROSSINGS

MC 0 : Eastern Boundary Road
MC 1 : Highway A1085
MC 2 : YPL 1st access road
MC 3 : Hot metal rail
MC 4 : NWL 2nd access road
MC 5 : National power grid lines
MC 6 : SSI road bridge
MC 7 : National rail way
MC 8 : Access NWL W.T.P.
MC 9 : Outfall

- Pass over in bridge
- Pass over in bridge
- Pass over in bridge
- Pass over in bridge
- Pass over in bridge
- Pass under
- Pass over in bridge
- Pass over in bridge
- Pass over in bridge
- Pass over in bridge

KEY PLAN
SCALE 1:50000

NOTES

LEGEND - CONVEYOR

- TYPE 3 - OPEN CONVEYOR - 2 LEGS
- TYPE 4 - OVAL ENCLOSED CONVEYOR - 2 LEGS
- TRANSFER TOWER
- ACCESS ROADS
- CONVEYOR FOOTINGS
- CONVEYOR AT THE QUAY

LEGEND - EXISTING SERVICES

- EASEMENT ZONES
- GAS - BP CATS
- GAS - GDF SUEZ
- GAS - RWE
- FIBRE OPTIC CABLE
- MISC - DRAINS, CABLES, DUCTS
- FOUL WATER - SEMBCORP
- WATER MAINS - NWL (NO EASEMENT IDENTIFIED)
- EFFLUENT - NWL
- GAS - ABANDONED
- SEMBORP ABOVEGROUND PIPELINE CORRIDOR
- OVERHEAD POWER CABLES
- 11/66KV ELECTRIC & BT DUCT - NWL
- LV SUPPLY TO ROAD LIGHTING AND BT DUCT - NWL
- ABOVE GROUND & BELOW GROUND PIPELINES AND ASSOCIATED BURIED ELECTRIC CABLE - NWL
- CARGO FLEET 900 DIA, ESTON 600 DIA, SBDO 150 DIA, RAW WATER, 11KV, VARIOUS COMMS CABLES - NWL
- CONVEYOR LIMITS OF DEVIATION

H	02.11.15	GAS-BP CATS PIPELINE REVISIONS	LW	CDJ	RP
G	10.09.15	NWL SERVICES UPDATED	LW	CDJ	DGB
F	01.09.15	MINOR REVISIONS (NWL SERVICES)	LW	CDJ	DGB
E	10.03.15	PLANNING ISSUE	LW	DGB	MH
D	16.03.15	MINOR REVISIONS	CH	DGB	MH
C	11.03.15	MINOR REVISIONS	LW	DGB	MH
B	08.03.15	ISSUED FOR INFORMATION	TF	DGB	MH
A	03.02.15	ISSUED FOR INFORMATION	LW	DGB	SM
REV	DATE	DESCRIPTION	BY	CHK	APP

YORKPOTASH
A Sirius Minerals Project

PROJECT
YORK POTASH

TITLE
THE YORK POTASH
HARBOUR FACILITIES ORDER 201X
CONVEYOR ROUTE PLANS
SOUTHERN ROUTE - SHEET 3
REGULATION 5(2)(o) DOCUMENT 3.3D

HASKONINGDHV UK LTD
MARITIME & WATERWAYS
Marlborough House
Marlborough Crescent
Newcastle upon Tyne NE1 4EE
+44 (0) 191 211 1300 Telephone
+44 (0) 191 211 1313 Fax
info@haskoningdhv.com E-mail
www.haskoningdhv.com Internet

ROYAL HASKONINGDHV
Enhancing Society Together

DRAWN	LW	CHECKED	DGB	PASSED	SM
DATE	JAN'15	CLIENT'S REF.			
SCALE AT A1	1:1000	AUTOCAD REF.	PB1586-SK1043		
DRAWING No.	PB1586-SK1043				REVISION
					H