



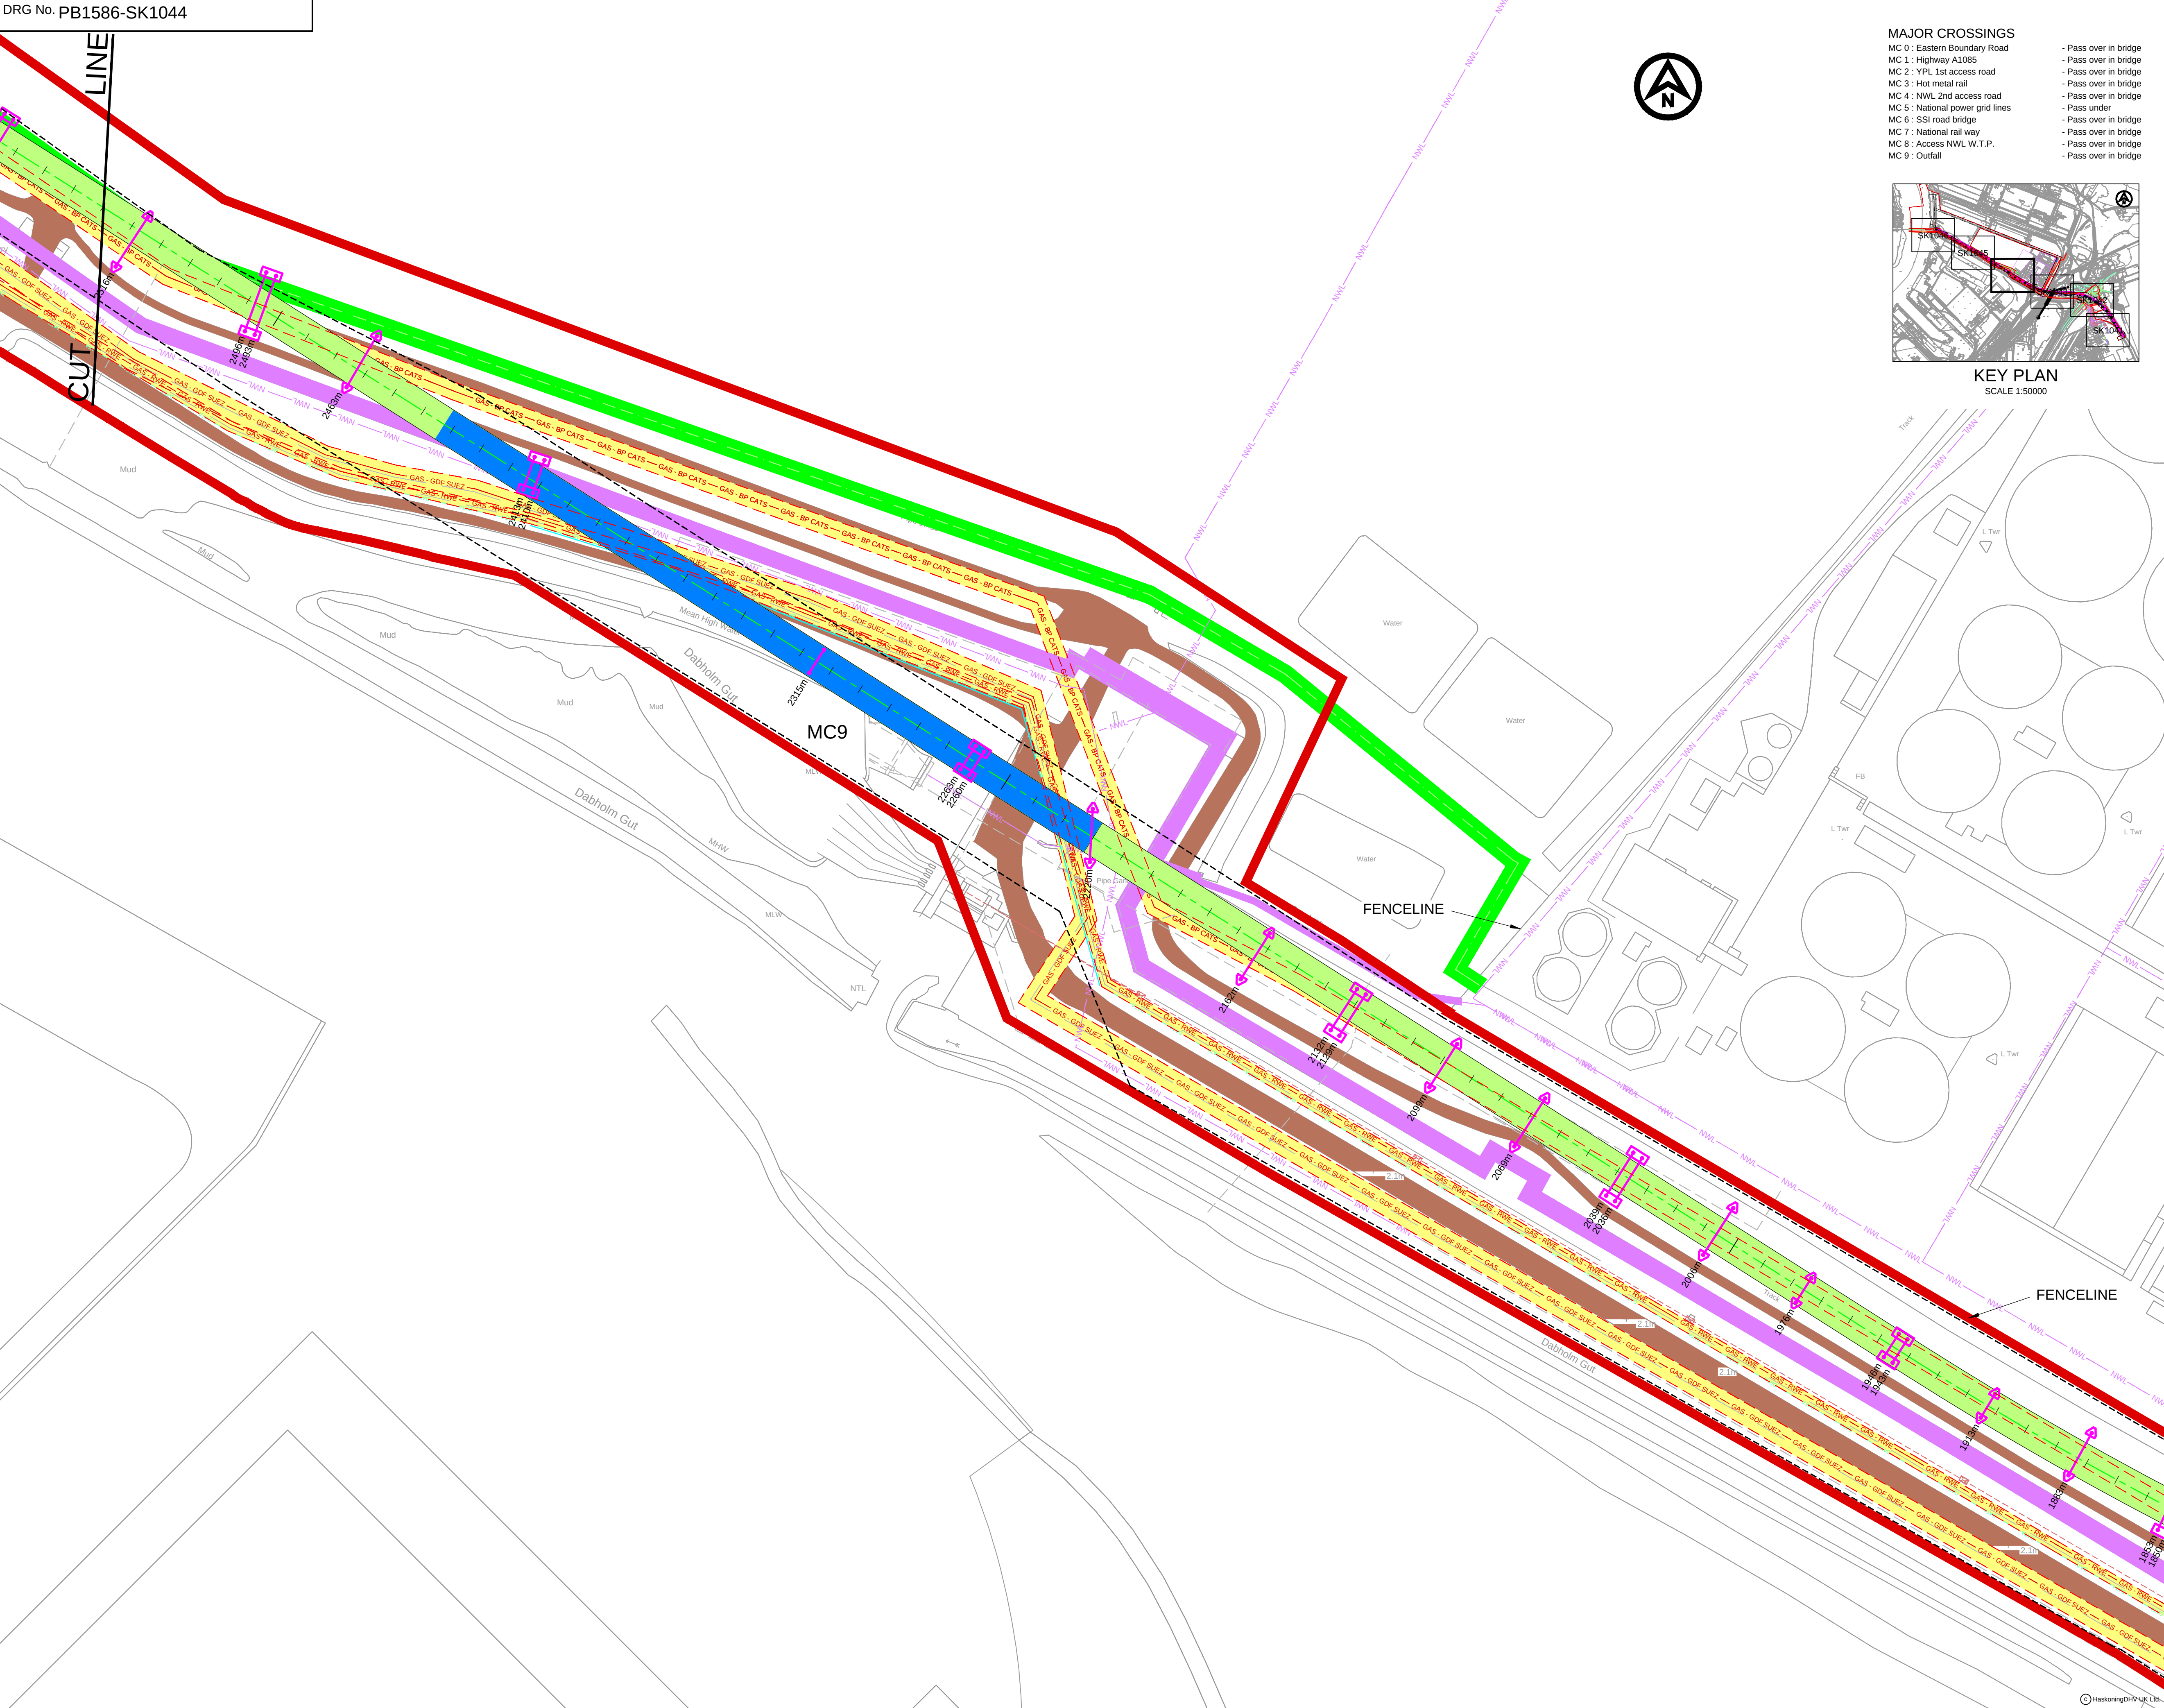

- MAJOR CROSSINGS**
- MC 0 : Eastern Boundary Road
 - MC 1 : Highway A1085
 - MC 2 : YPL 1st access road
 - MC 3 : Hot metal rail
 - MC 4 : NWL 2nd access road
 - MC 5 : National power grid lines
 - MC 6 : SSI road bridge
 - MC 7 : National rail way
 - MC 8 : Access NWL W.T.P.
 - MC 9 : Outfall
- Pass over in bridge
 - Pass over in bridge
 - Pass over in bridge
 - Pass over in bridge
 - Pass over in bridge
 - Pass under
 - Pass over in bridge
 - Pass over in bridge
 - Pass over in bridge
 - Pass over in bridge

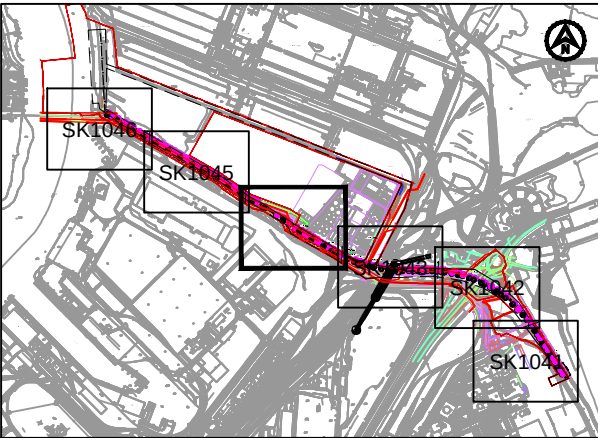

KEY PLAN
SCALE 1:50000

- NOTES**
- LEGEND - CONVEYOR**
- TYPE 3 - OPEN CONVEYOR - 2 LEGS
 - TYPE 4 - OVAL ENCLOSED CONVEYOR - 2 LEGS
 - TRANSFER TOWER
 - ACCESS ROADS
 - CONVEYOR FOOTINGS
 - CONVEYOR AT THE QUAY
- LEGEND - EXISTING SERVICES**
- EASEMENT ZONES
 - GAS - BP CATS
 - GAS - GDF SUEZ
 - GAS - RWE
 - FIBRE OPTIC CABLE
 - MISC - DRAINS, CABLES, DUCTS
 - FOUL WATER - SEMBCORP
 - WATER MAINS - NWL (NO EASEMENT IDENTIFIED)
 - EFFLUENT - NWL
 - GAS - ABANDONED
 - SEMSCORP ABOVEGROUND PIPELINE CORRIDOR
 - OVERHEAD POWER CABLES
 - 11/66KV ELECTRIC & BT DUCT - NWL
 - LV SUPPLY TO ROAD LIGHTING AND BT DUCT - NWL
 - ABOVE GROUND & BELOW GROUND PIPELINES AND ASSOCIATED BURIED ELECTRIC CABLE - NWL
 - CARGO FLEET 900 DIA, ESTON 600 DIA, SBCO 150 DIA, RAW WATER, 11KV, VARIOUS COMMS CABLES - NWL
 - CONVEYOR LIMITS OF DEVIATION

H	02.11.15	GAS-BP CATS PIPELINE REVISIONS	LW	CDJ	RP
G	10.09.15	NWL SERVICES UPDATED	LW	CDJ	DGB
F	01.09.15	MINOR REVISIONS (NWL SERVICES)	LW	CDJ	DGB
E	10.03.15	PLANNING ISSUE	LW	DGB	MH
D	16.03.15	MINOR REVISIONS	CH	DGB	MH
C	11.03.15	MINOR REVISIONS	LW	DGB	MH
B	08.03.15	ISSUED FOR INFORMATION	TF	DGB	MH
A	05.02.15	ISSUED FOR INFORMATION	LW	DGB	SM
REV	DATE	DESCRIPTION	BY	CHK	APP

REVISIONS



PROJECT

YORK POTASH

TITLE

**THE YORK POTASH
HARBOUR FACILITIES ORDER 201X
CONVEYOR ROUTE PLANS
SOUTHERN ROUTE - SHEET 4
REGULATION 5(2)(o) DOCUMENT 3.3E**



DRAWN	LW	CHECKED	DGB	PASSED	SM
-------	----	---------	-----	--------	----

DATE	JAN'15	CLIENT'S REF.	
------	--------	---------------	--

SCALE AT A1	1:1000	AUTOCAD REF.	PB1586-SK1044
-------------	--------	--------------	---------------

DRAWING No.	PB1586-SK1044	REVISION	H
-------------	---------------	----------	---