

BENZOLE STORAGE TANKS (x3)
246 Te

CREOSOTE OIL
321 Te

COAL TAR
523 TONNES

COKE OVEN
GASHOLDER
40.1 TONNES +
SEALANT 65 TONNES

GASHOLDER
SEALANT
STORAGE
37 TONNES

LIQUID OXYGEN
STORAGE VESSEL
4.6 TONNES



Sahaviriya Steel Industries


RECEIVED

- 6 AUG 2012

ENGINEERING PLAN

ITEM	No.	MATERIAL	DESCRIPTION	REMARKS	WORTH OF ONE ITEM

DRAWN BY		DATE		WORKS		CLEVELAND		PLANT		GENERAL	
M.Morris		26 July 2012									
CHECKED BY		DATE		SUB SECTION		WORKS PLANS		PLANS & WORKS LAYOUTS			
APPROVED BY		DATE									

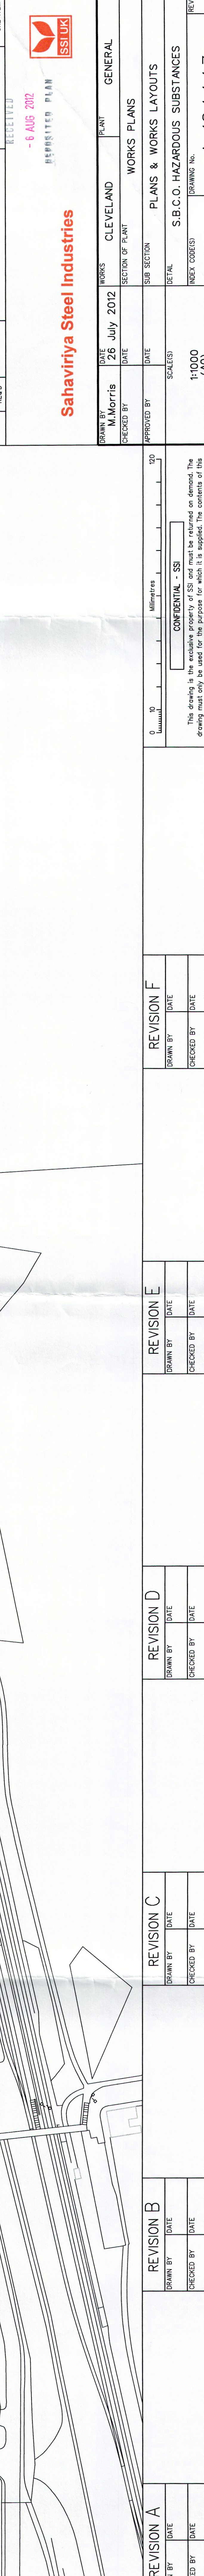

REVISION A		REVISION B		REVISION C		REVISION D		REVISION E		REVISION F	
DRAWN BY	DATE	DRAWN BY	DATE	DRAWN BY	DATE	DRAWN BY	DATE	DRAWN BY	DATE	DRAWN BY	DATE
CHECKED BY	DATE	CHECKED BY	DATE	CHECKED BY	DATE	CHECKED BY	DATE	CHECKED BY	DATE	CHECKED BY	DATE
APPROVED BY	DATE	APPROVED BY	DATE	APPROVED BY	DATE	APPROVED BY	DATE	APPROVED BY	DATE	APPROVED BY	DATE

0 10 20 30

Metres

CONFIDENTIAL - SSI

This drawing is the property of Sahaviriya Steel Industries and is not to be reproduced or copied without the written permission of the company. The contents of this drawing are strictly confidential and must not be used for any other purpose. If the drawing is to be used for any other purpose, the permission must be obtained from the company. The company is not responsible for any loss or damage caused by the use of this drawing.

ISSUED: 11/000 (A0)

REVISION No. WP1

REV. A-124443

Copyright - SSI ©