


VISUAL SCALE 1:100

A-0022  
E

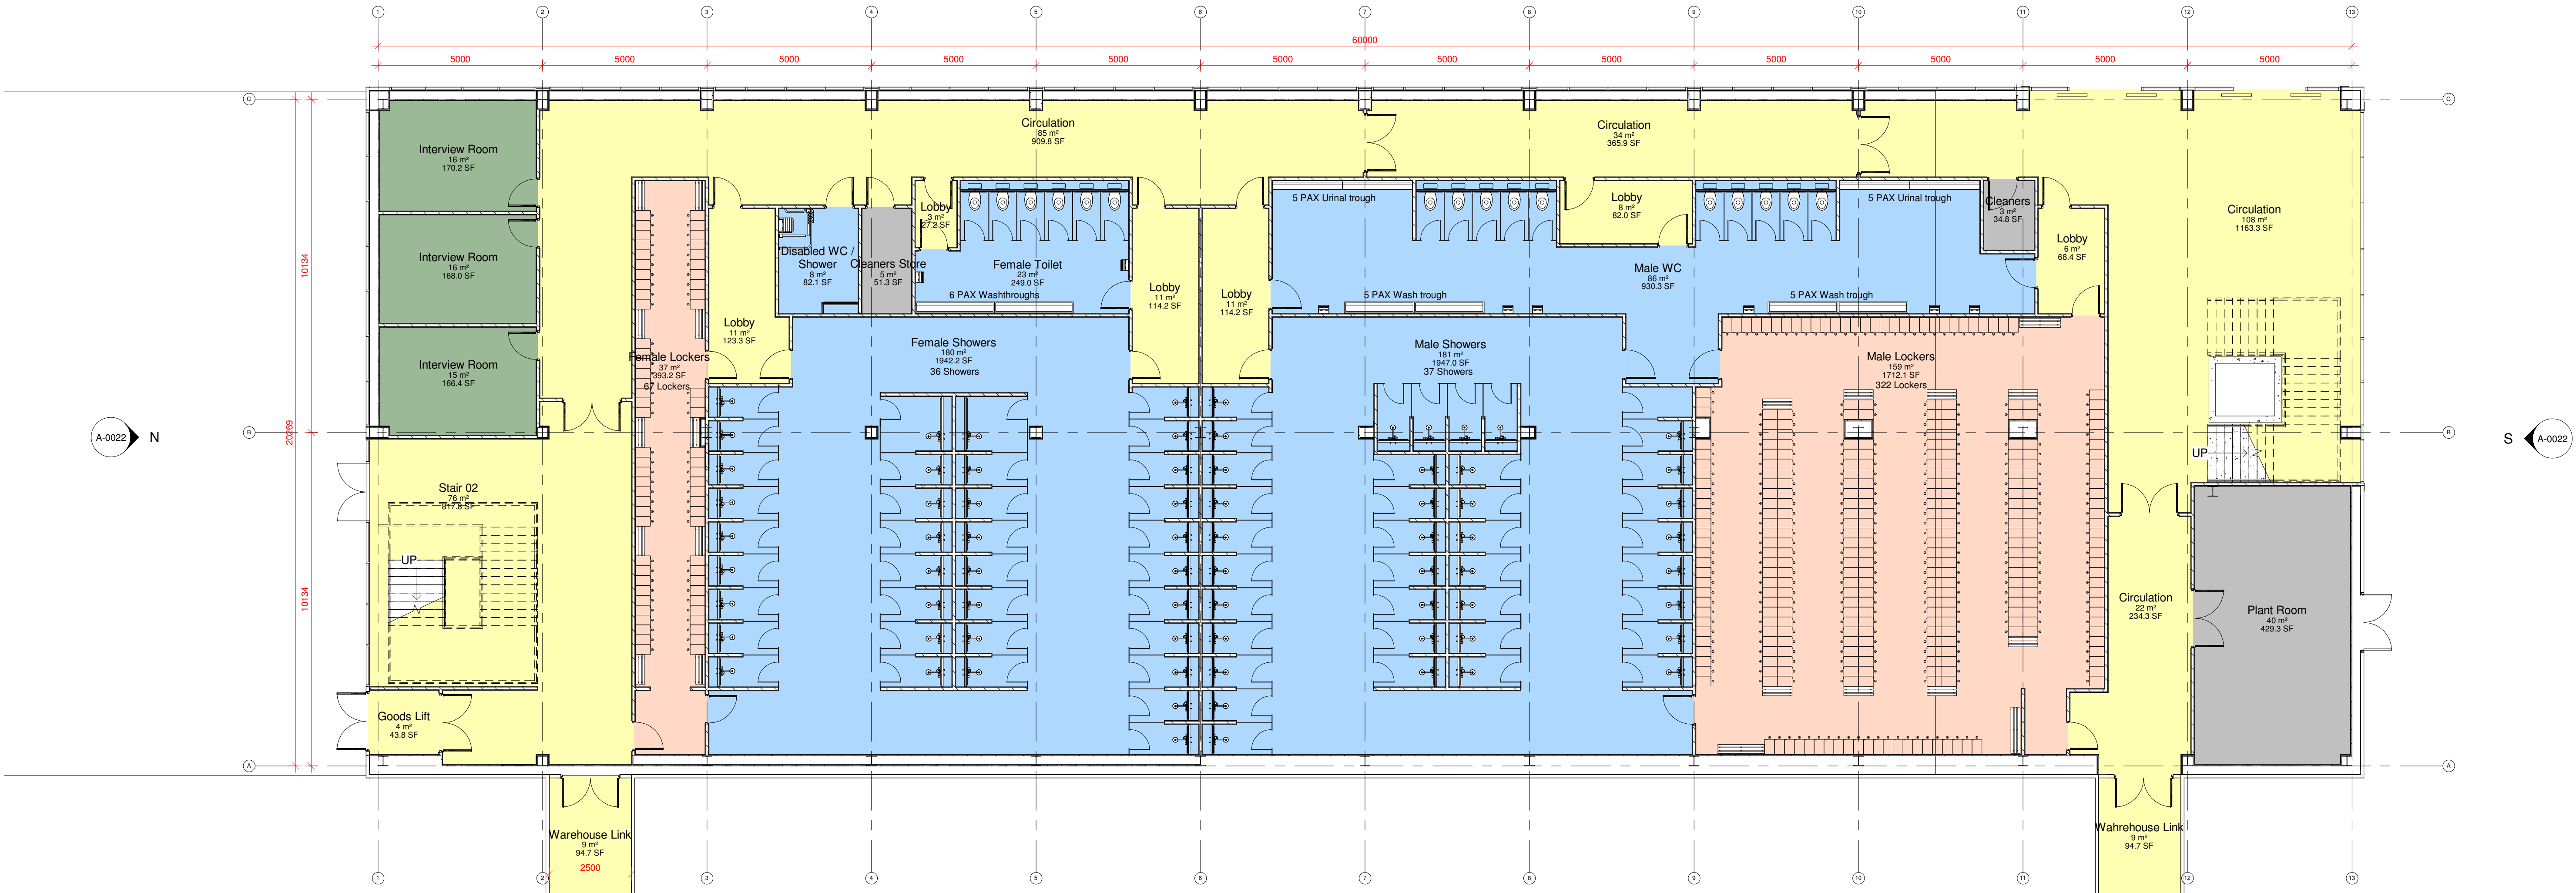

1 Ground Floor Level  
1 : 100

A-0022  
W

By Department Legend

- Circulation
- Lockers
- Offices
- Stores
- Toilets & Showers

Do not scale this drawing  
ashton smith to be notified of discrepancies in figured dimensions  
Contractors must check all dimensions from site  
This drawing is copyright and is for use on this site only  
This drawing is to be used solely for information as entitled  
For other information refer to the latest revision of any cross referenced drawing




LOCATION PLAN:

NOTES:

P1	25/03/22	First Issue
REV	DATE	DESCRIPTION
REVISIONS		
DRAWN BY		CHECK BY

PROJECT TITLE SeAH Monopile Facility					
DRAWING TITLE Workers Room Ground Floor Plan					
RIBA STAGE	STATUS		DRAWN BY	CHECKED BY	
	Planning		JVS	RB	
SHEET	SCALE	DATE	SUITABILITY	REVISION	P1
A1	1 : 100	25/03/22	S0		
DRAWING NO. SEAH - ASA - 00 - WR.G3 - D - A - 0019 _ (S0 - P1)					
BIM MODEL NUMBER: SEAH-ASA-ZZ-WR-ZZ-M3-A-0006_(S0-P01)					

CLIENT	
 Beyond Design	
Ashton Smith, Belvedere House, 2 Victoria Avenue, Harrogate, North Yorkshire, HG1 3EL Tel: 01423 522882 Fax: 01423 565104 www.ashtonsmith.co.uk	

JOB NO.  
22016